


The Montrachet Dream Home 2021



(ORIGINAL COVER ART - FINAL DESIGN MAY VARY)


COMMUNITY MAP

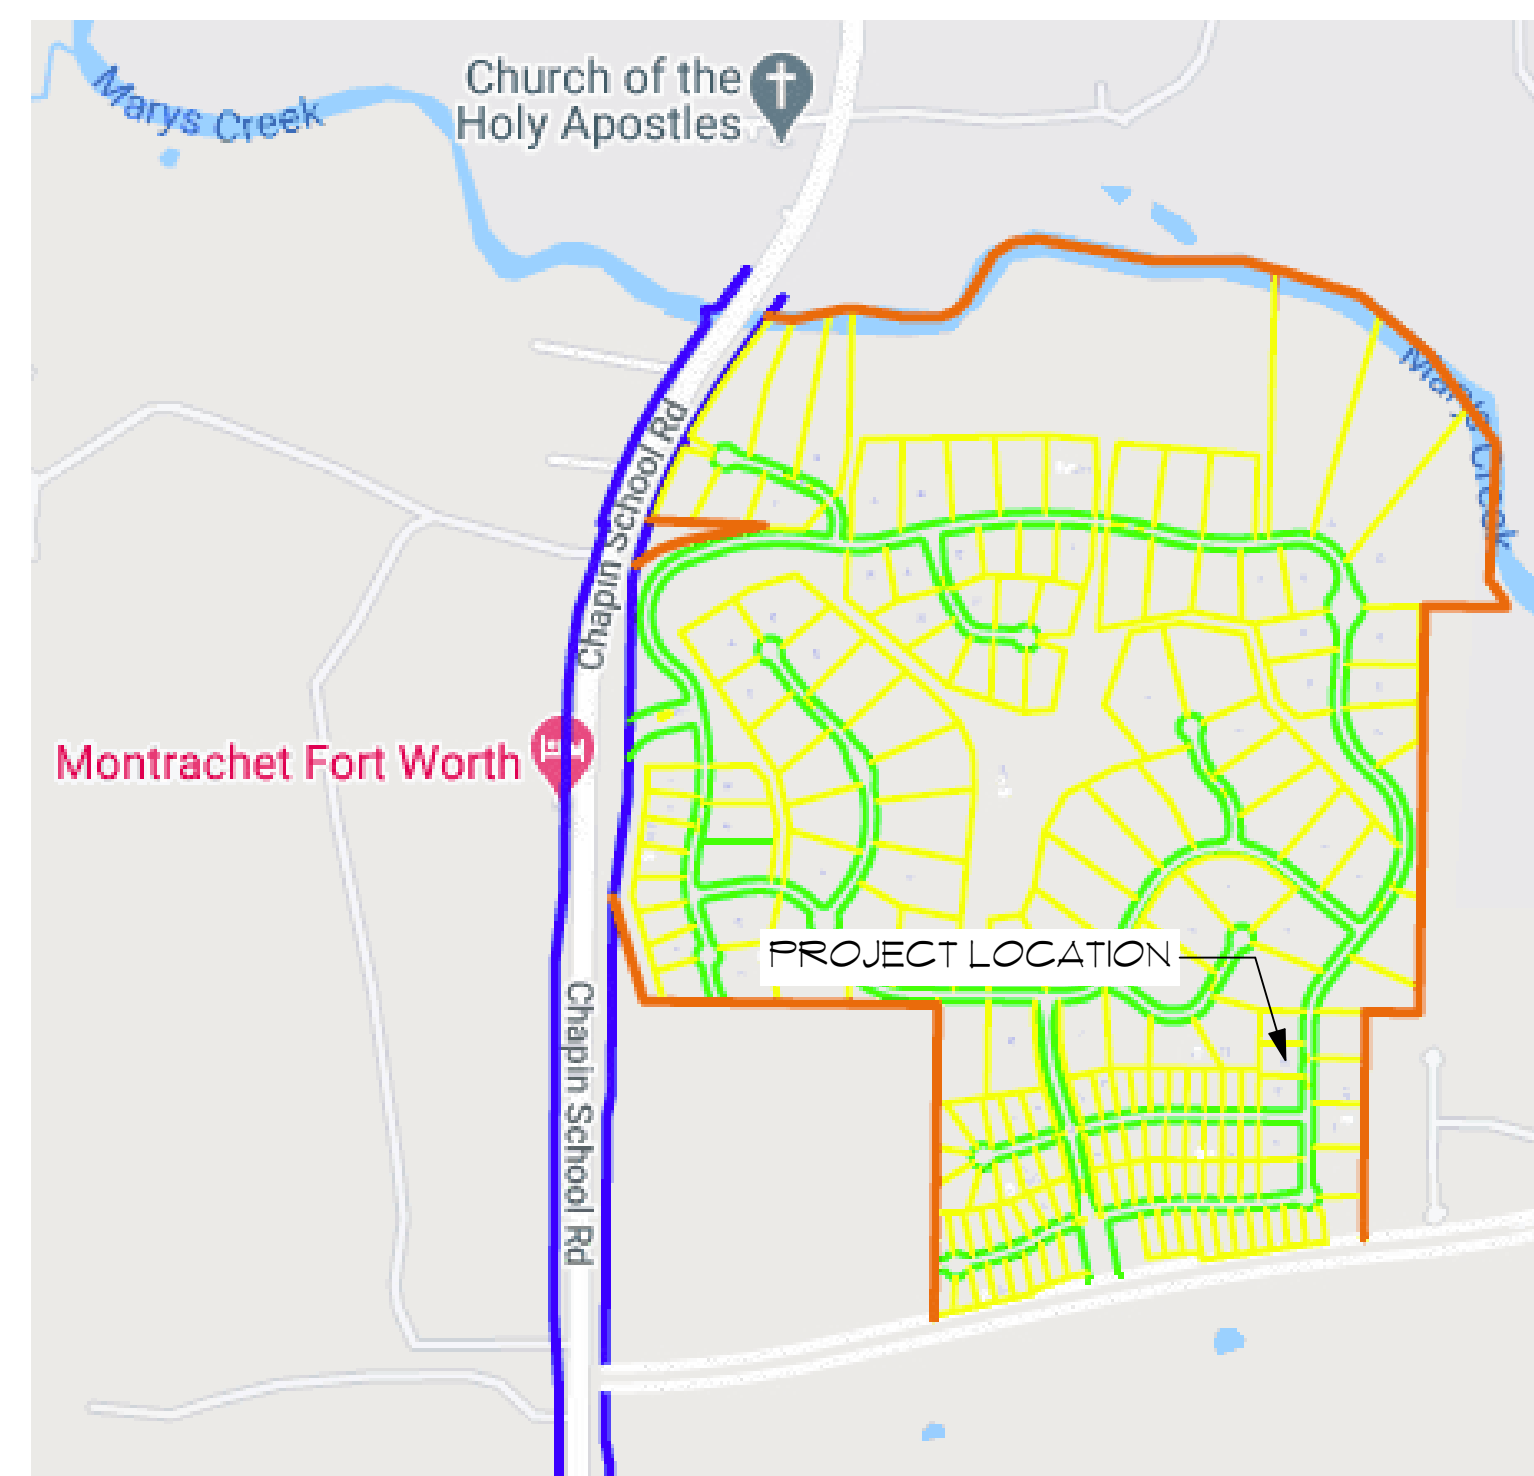

SYMBOL LEGEND	
	DOOR MARKER
	EXTERIOR DOOR MARKER
	WINDOW MARKER
	OPENING MARKER
	SECTION MARKER
	DETAIL MARKER
	ELEVATION MARKER
	ROOF SLOPE INDICATOR

TABLE OF CONTENTS	
ID	NAME
A1-00	COVER SHEET
A1-01	SITE PLAN
A2-01	MAIN LEVEL FLOOR PLAN
A2-02	ATTIC PLAN
A2-03	FORM SET PLAN
A2-04	MAIN LEVEL RCP
A3-01	ROOF PLAN
A3-02	ROOF DETAILS
A4-01	FRONT & BACK ELEVATIONS
A4-02	SIDE ELEVATIONS
A4-03	COURTYARD ELEVATIONS
A4-04	SECTIONS
A4-05	SECTIONS CONTINUED
A5-01	DOOR & OPENING TYPES
A5-02	WINDOW TYPES
A5-03	DETAILS
E1-01	MAIN LEVEL ELECTRICAL PLAN

596 North Kimball
Suite 100
Southlake, Texas 76092
817 • 988 • 9680 (OFFICE)
www.HeritageDesignStudio.com
office@HeritageDesignStudio.com

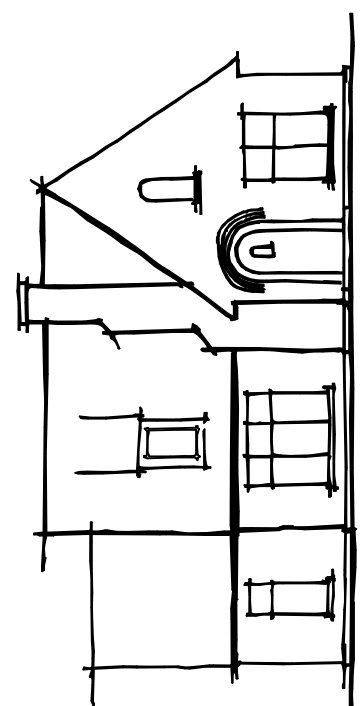

Heritage
DESIGN STUDIO

Montrachet Dream Home 2021

Design Version No: Version 3
LOT 23
FORT WORTH, TX, 76126
Project Status:
Construction Documents
Project No:
2072

For regulatory approval, permitting, or construction.

Dates:
Project Start Date: December 7th 2020
Date Printed: Tuesday, March 2, 2021
Project Version Number: Version 3

Internal Information:
CAD File Name: Montrachet Dream Home 2021 (A1-00.dwg)
File last saved on: 3/2/21, 2:36 PM
Designed By: Christopher D. Hougl
File Path: S:\Projects\2021\Montrachet\2021 Heritage Montrachet 12582\WACAD\Montrachet Dream Home 2021.dwg
Roof (h)

This drawing checked by:

Sheet Number:
A1-00
Sheet Name:
COVER SHEET